



Banque plan

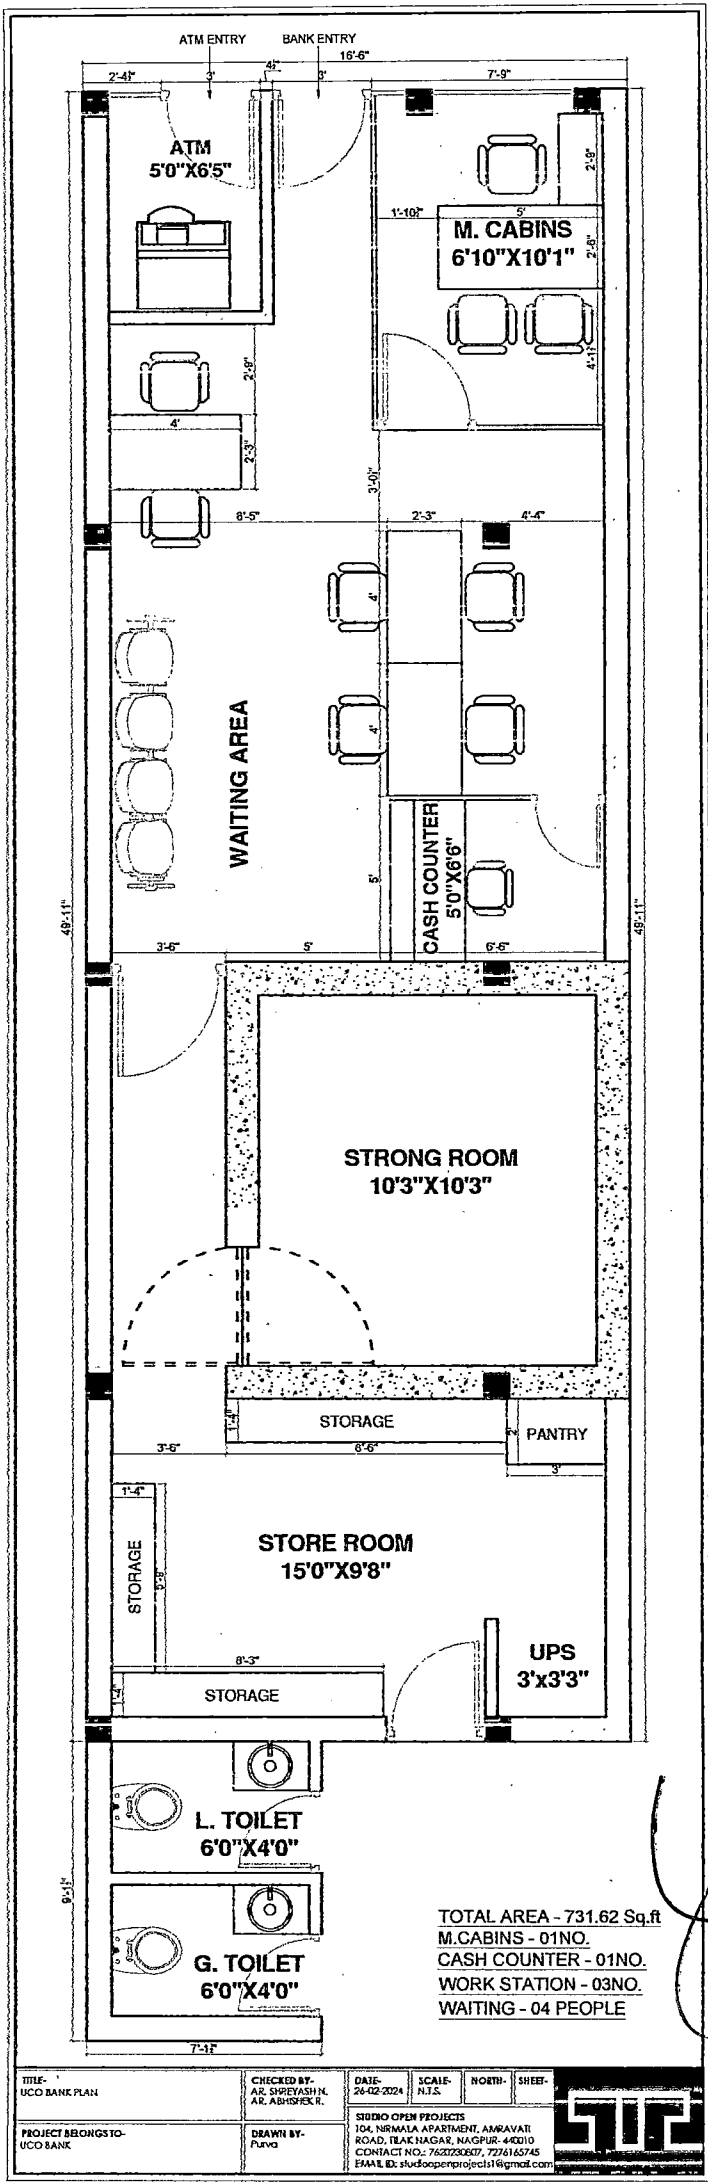


TOTAL AREA - 731.62 Sq.ft
 M.CABINS - 01NO.
 CASH COUNTER - 01NO.
 WORK STATION - 03NO.
 WAITING - 04 PEOPLE

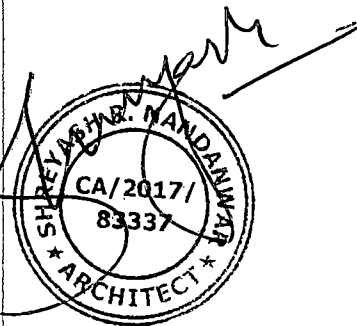

TITLE - UCO BANK PLAN	CHECKED BY - A.K. SHREYASHIL A.K. ARCHITECTS, I.	DATE - 26-02-2024	SCALE - N.T.S.	NORTH -	SHEET -
PROJECT BEHNGS TO - UCO BANK	DRAWN BY - Purva	SIDHO OPEN PROJECTS 104, NIRMALA APARTMENT, AMRAVATI ROAD, TEAK NAGAR, NAGPUR - 440110 CONTACT NO.: 7629723667, 7746165745 EMAIL ID: sidhoopenprojects@gmail.com			



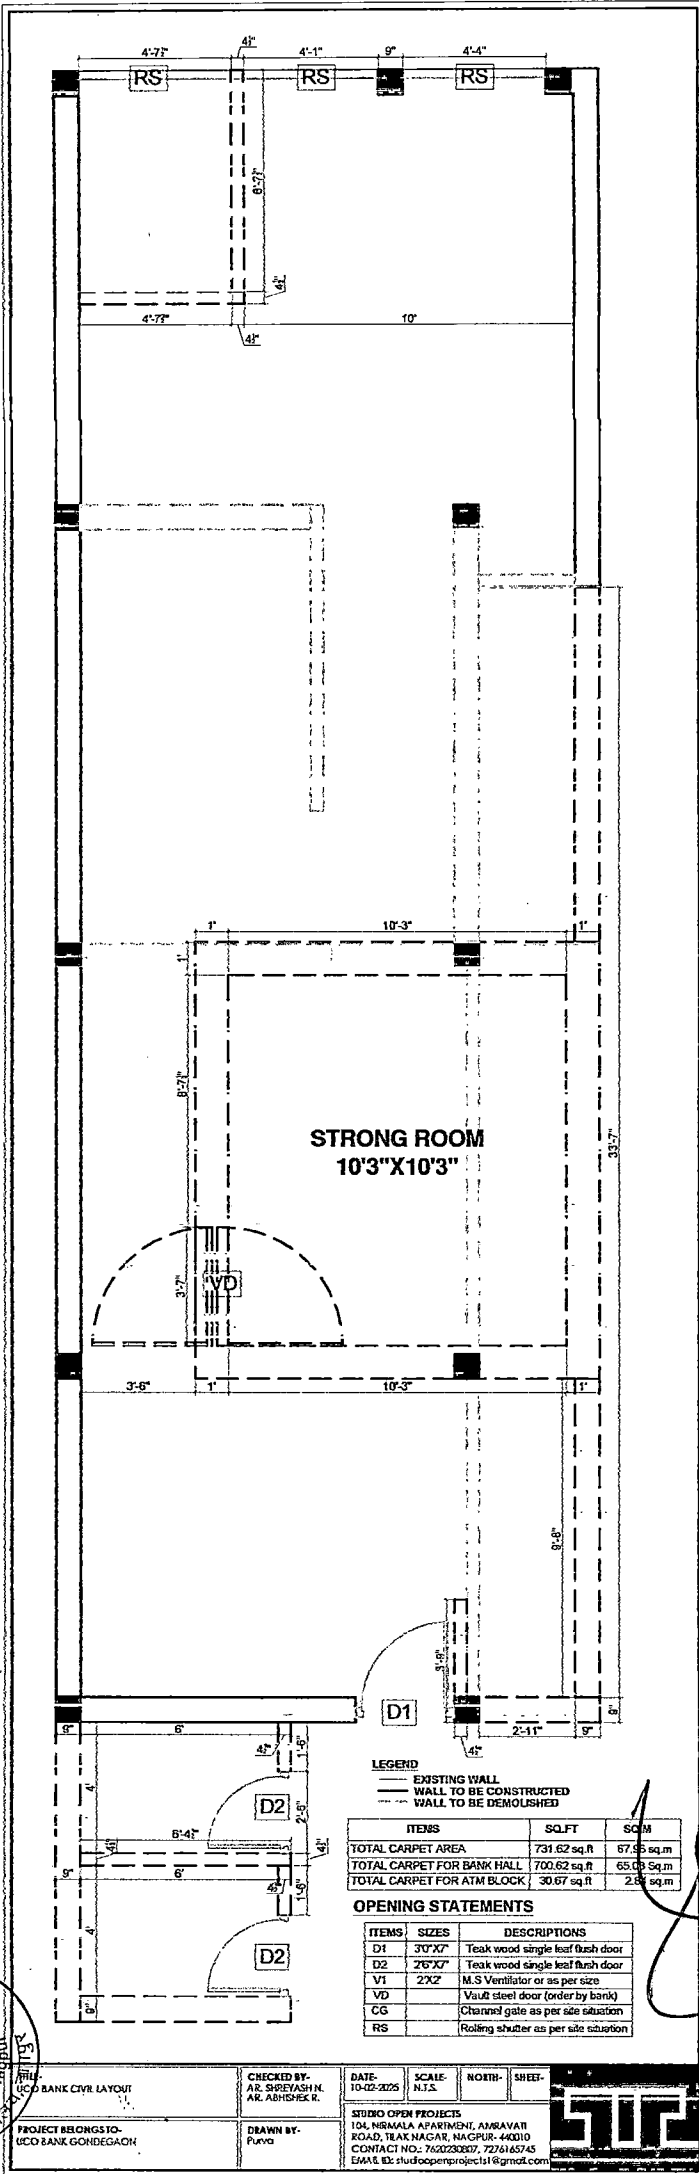


STRONG ROOM
10'3"X10'3"

LEGEND
 — EXISTING WALL
 — WALL TO BE CONSTRUCTED
 - - - WALL TO BE DEMOLISHED

ITEMS	SQ.FT	SQM
TOTAL CARPET AREA	731.62 sq.ft	67.95 sq.m
TOTAL CARPET FOR BANK HALL	700.62 sq.ft	65.09 sq.m
TOTAL CARPET FOR ATM BLOCK	30.67 sq.ft	2.86 sq.m


OPENING STATEMENTS

ITEMS	SIZES	DESCRIPTIONS
D1	30'X7'	Teak wood single leaf flush door
D2	26'X7'	Teak wood single leaf flush door
V1	2'X2'	M.S Ventilator or as per size
VD		Vault steel door (order by bank)
CG		Channel gate as per site situation
RS		Rolling shutter as per site situation

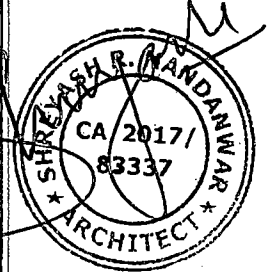


PROJECT BELONGS TO: UCO BANK GONDGAON	CHECKED BY: AR. SHREYASH R. AR. ABHISHEK R.	DATE: 10-02-2025	SCALE: N.I.S.	NORTH:	SHEET:
DRAWN BY: Purva	STUDIO OPEN PROJECTS 104, NIRMALA APARTMENT, AMRAVATI ROAD, TEAK NAGAR, NAGPUR-440010 CONTACT NO.: 762220887, 7276165745 EMAIL: studioopenprojects1@gmail.com				

False Layout

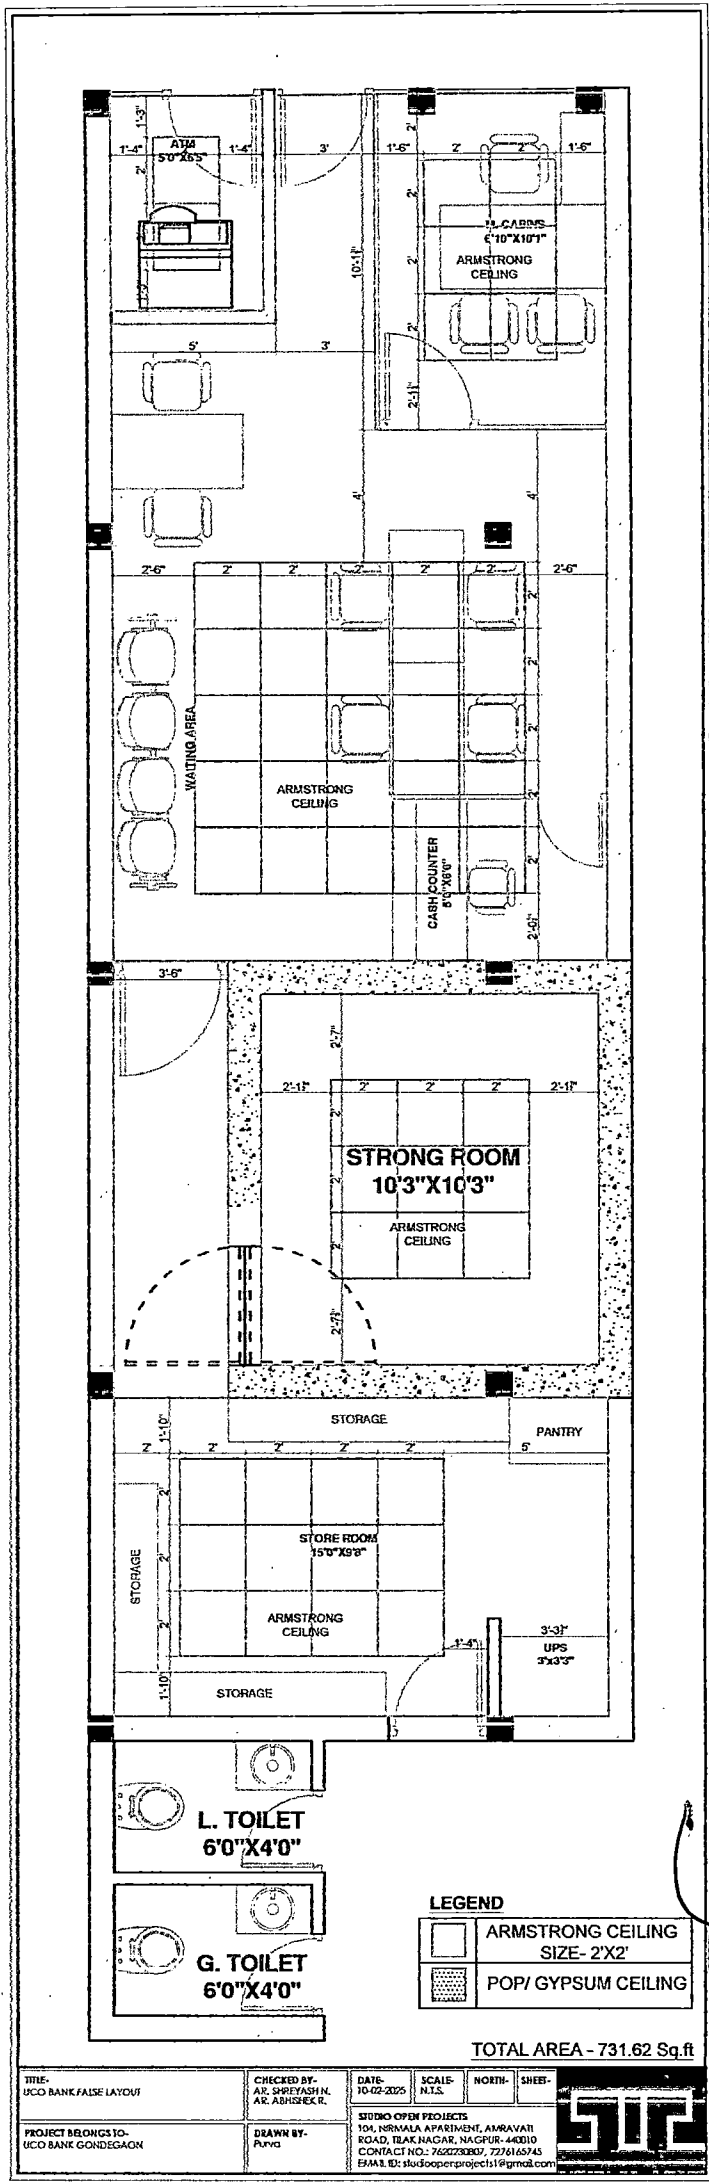

LEGEND

	ARMSTRONG CEILING SIZE- 2'X2'
	POP/ GYPSUM CEILING


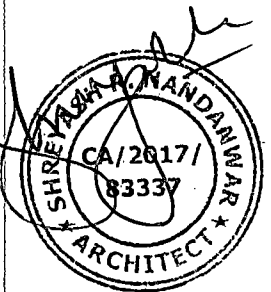


TOTAL AREA - 731.62 Sq.ft

TITLE: UCO BANK FALSE LAYOUT	CHECKED BY: AR. SHREYASHRI, AR. ARCHITECT	DATE: 10-02-2025	SCALE: N.T.S.	NORTH:	SHEET:
PROJECT BELONGS TO: UCO BANK GONDGAON	DRAWN BY: Purva	STUDIO OPEN PROJECTS 104, NIRMAA APARTMENT, AMRAVATI ROAD, BLAK NAGAR, NAGPUR-440110 CONTACT NO.: 7652730007, 771616745 EMAIL ID: studioopenproject1@gmail.com			



Light Fitting
Layout

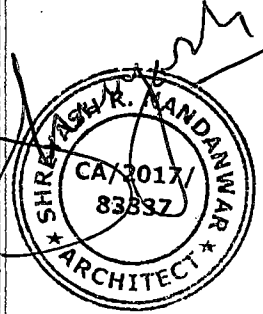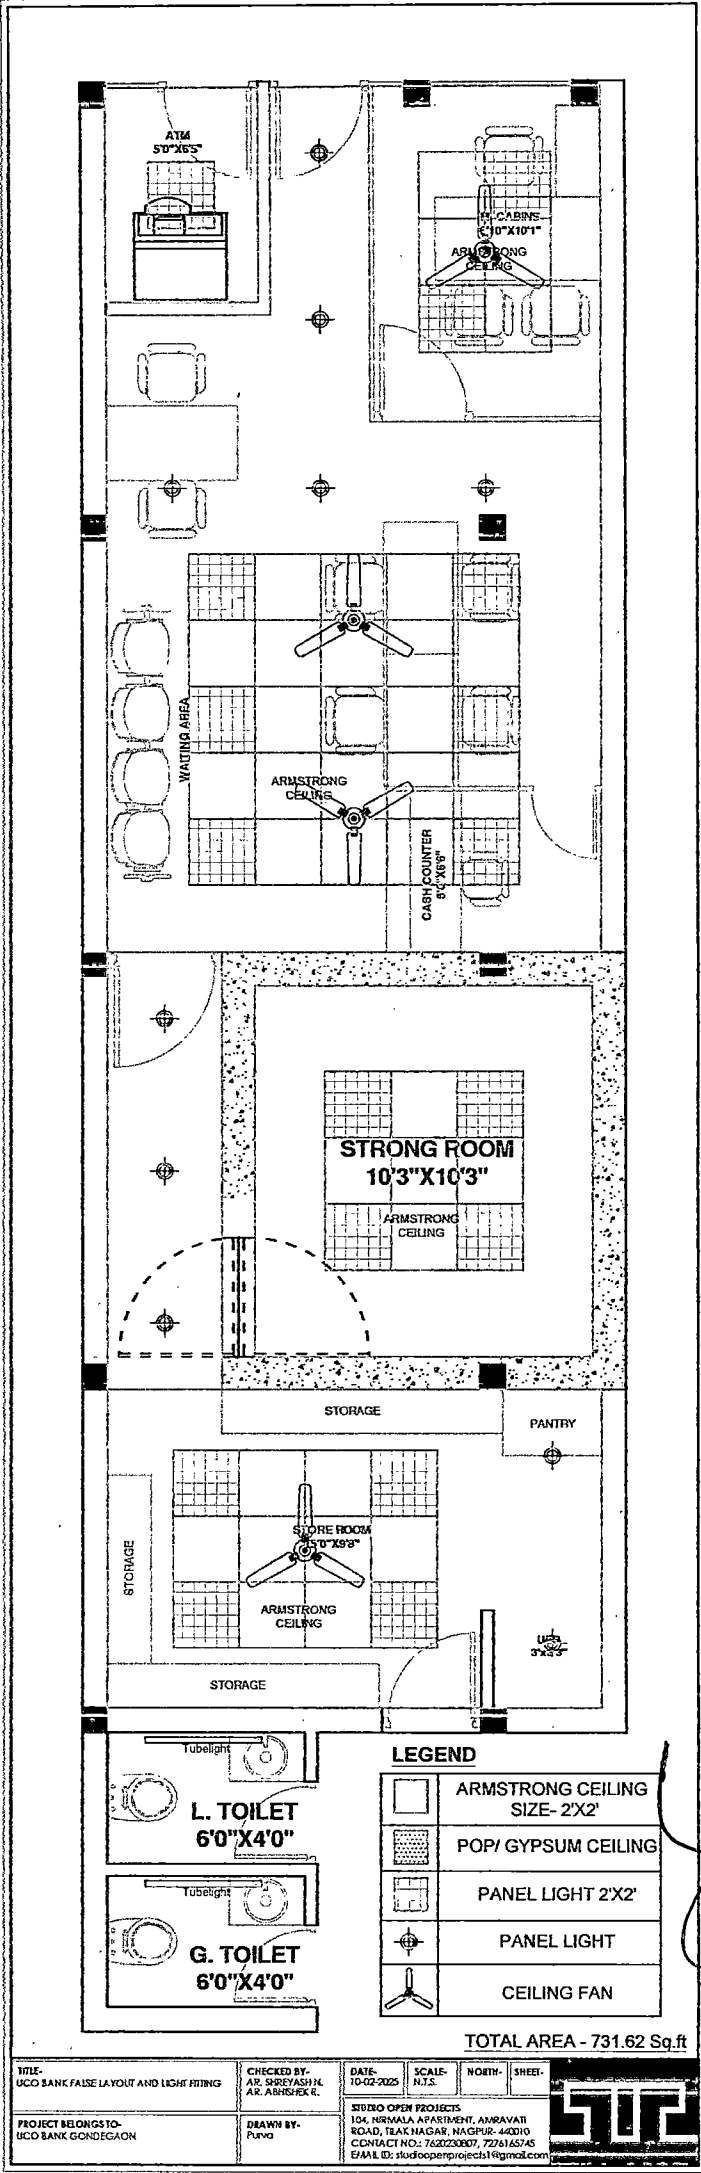


LEGEND

	ARMSTRONG CEILING SIZE- 2'X2'
	POP/ GYPSUM CEILING
	PANEL LIGHT 2'X2'
	PANEL LIGHT
	CEILING FAN

TOTAL AREA - 731.62 Sq.ft

TITLE: UCO BANK FALSE LAYOUT AND LIGHT FITTING	CHECKED BY: AR. SHREYASH R. AR. ABHISHEK L.	DATE: 10-02-2025	SCALE: N.T.S.	NORTH:	SHEET:
PROJECT BELONGS TO: UCO BANK GONDGAON	DRAWN BY: Purna	STUDIO OPEN PROJECTS 104, NIRMALA APARTMENT, ANNAVATI ROAD, TEAK NAGAR, NAGPUR- 440110 CONTACT NO: 7682220007, 7276165745 EMAIL ID: studopenproject1@gmail.com			



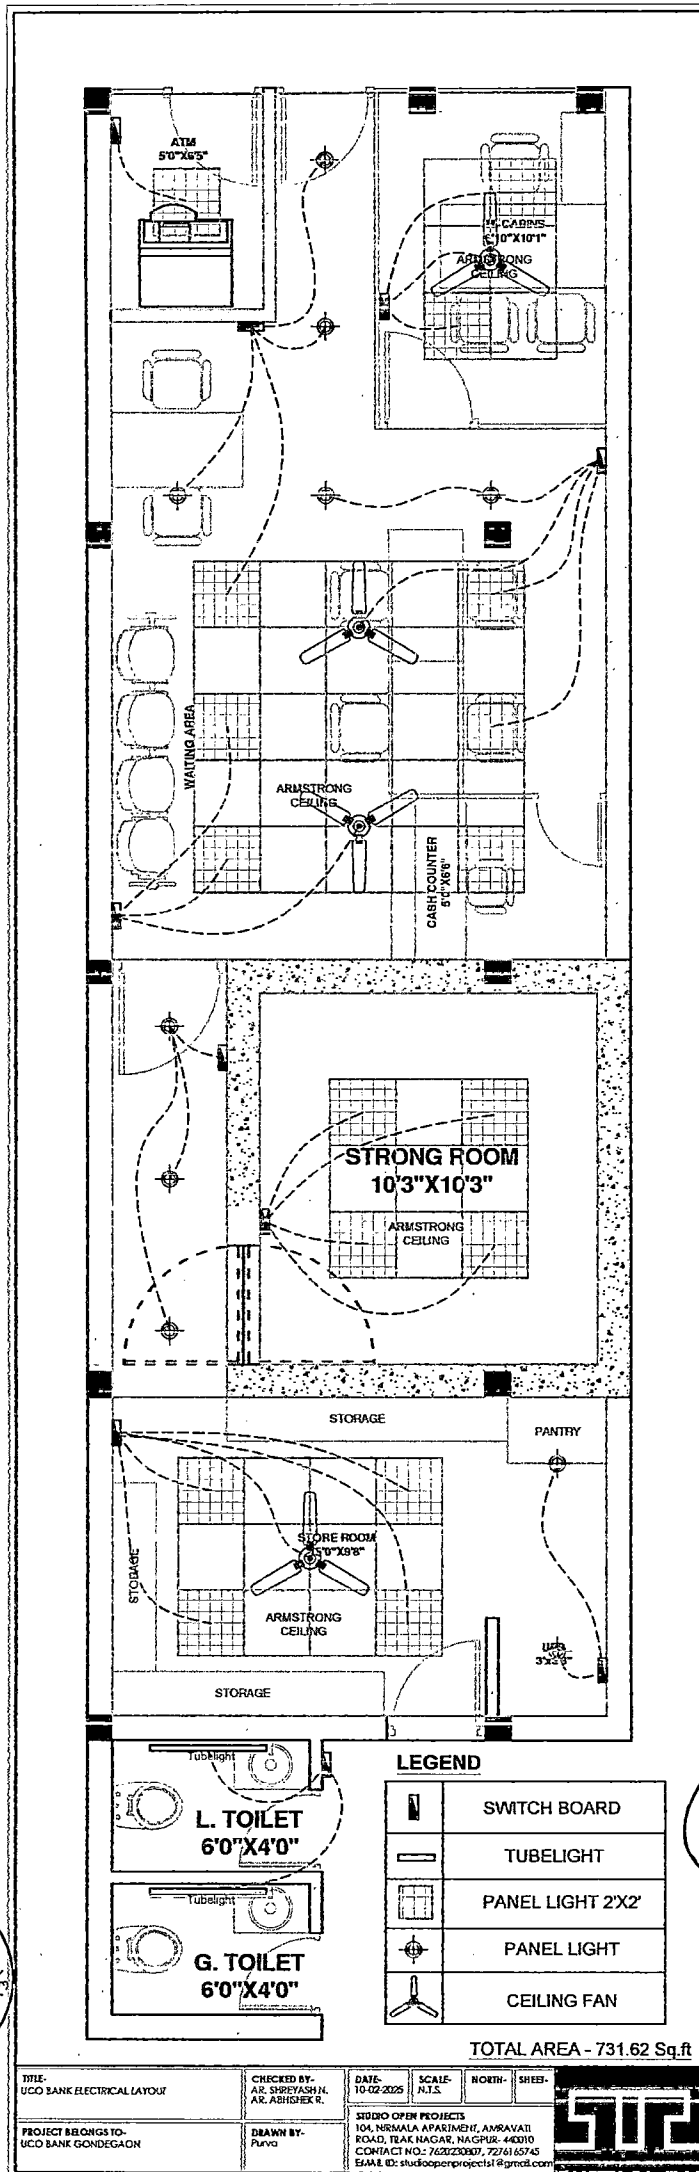

TOTAL AREA - 731.62 Sq.ft

TITLE: UCO BANK ELECTRICAL LAYOUT	CHECKED BY: MR. SHREYASH, MR. ABHIRAM R.	DATE: 10-02-2020	SCALE: N.T.S.	NO. OF SHEETS: 1	SHEET NO.: 1
PROJECT BELONGS TO: UCO BANK GONDEGAON	DRAWN BY: Purva	STUDIO OPEN PROJECTS 104, NIRMALA APARTMENT, AMRAVATI ROAD, TRAKNAGAR, NAGPUR-443110 CONTACT NO:- 725223087, 7276165745 EMAIL ID: studioopenprojects1@gmail.com			

